


BY: A Restivo  
 READINGS AT 1 METER / 12 meter  
 MICRO R/HOUR MODEL 19 LUDLUM  
 #91549 SERIAL

Partly Cloudy ~66° NNE wind

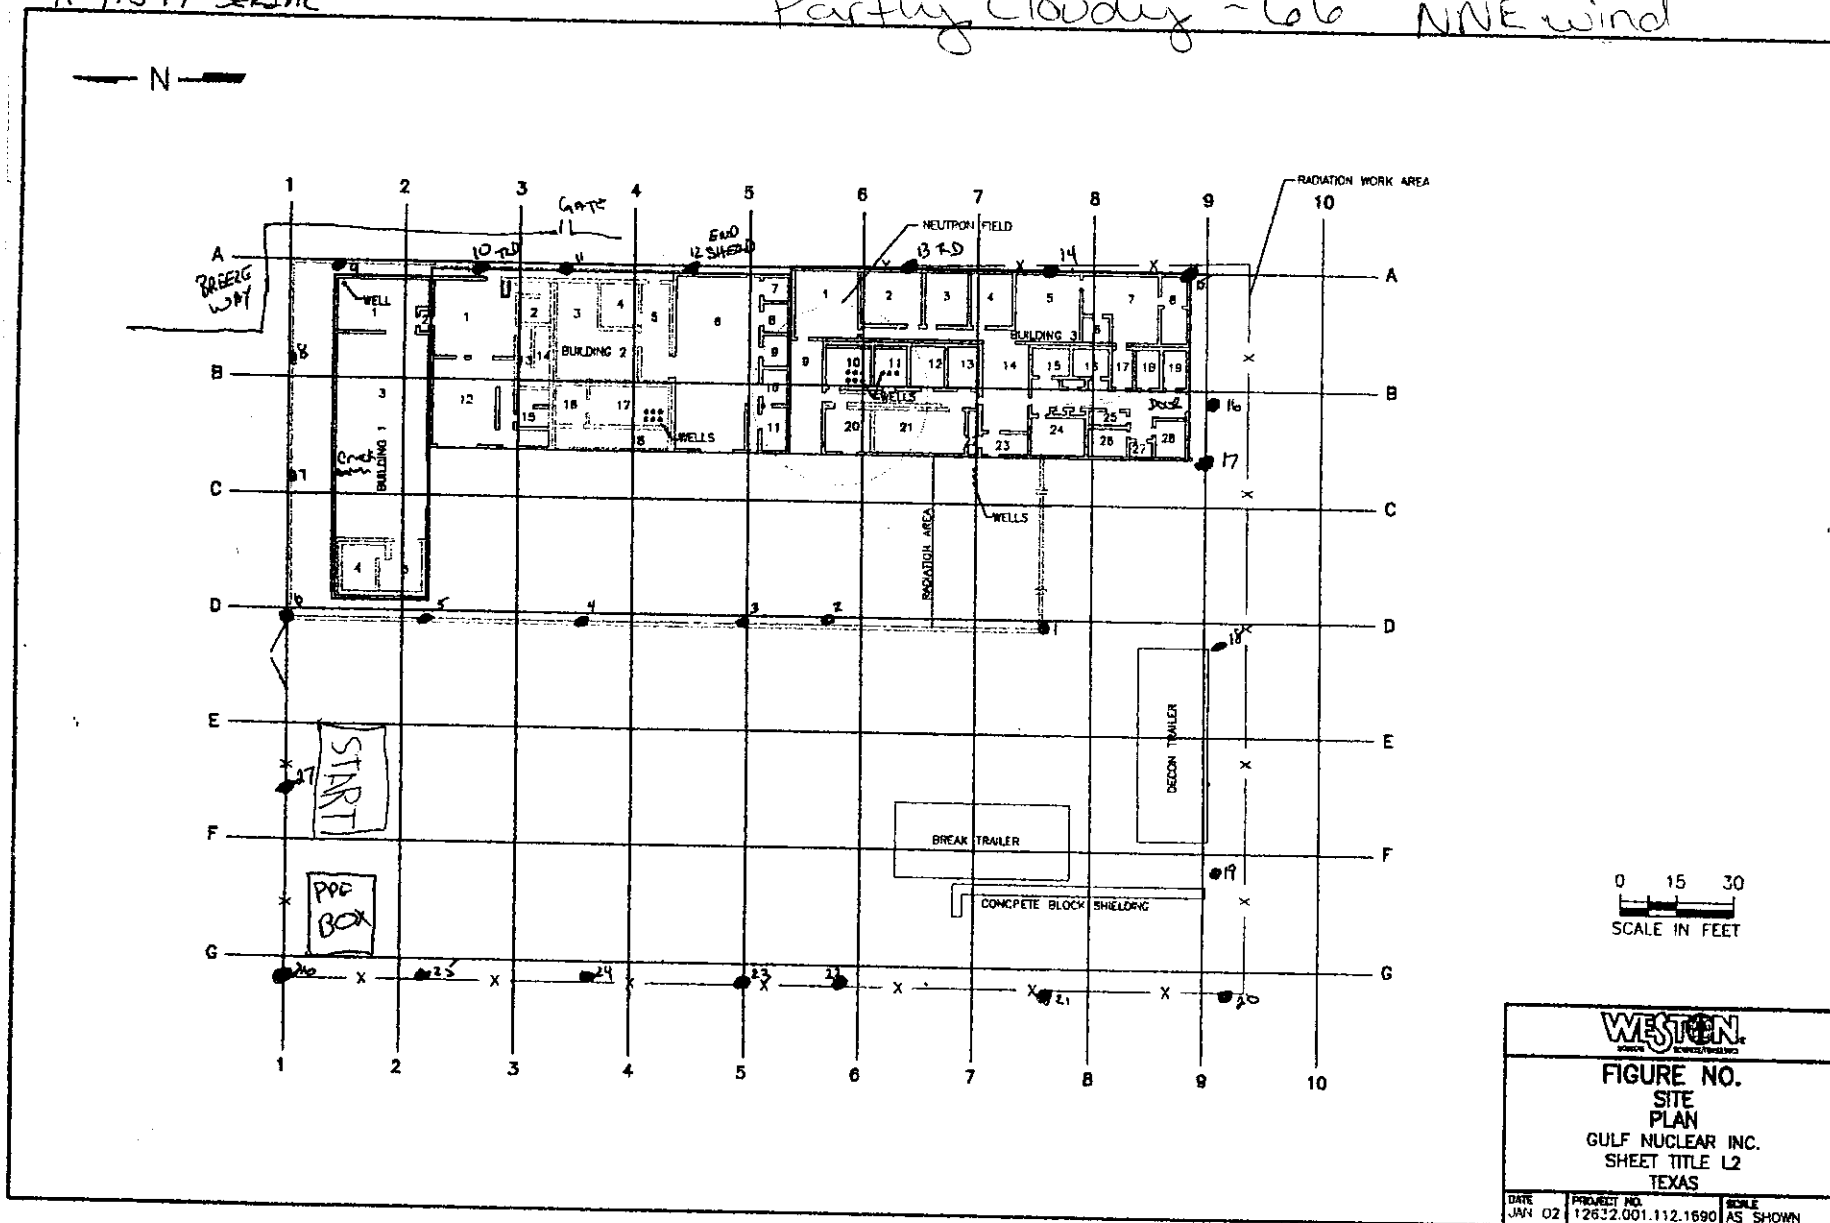

0 15 30  
 SCALE IN FEET

<b>WESTON</b> SPECIAL SERVICES/INSTRUMENTS		
FIGURE NO. SITE PLAN GULF NUCLEAR INC. SHEET TITLE L2 TEXAS		
DATE JAN 02	PROJECT NO. 12632.001.112.1690	SCALE AS SHOWN

SITE WORK DATE: 11/12/02 1630


BY: A Restivo

READINGS AT 1 METER / 2 meters

MICRO R/HOUR MODEL 19 LUDLUM

#91549 SERIAL


Partly Cloudy 66°

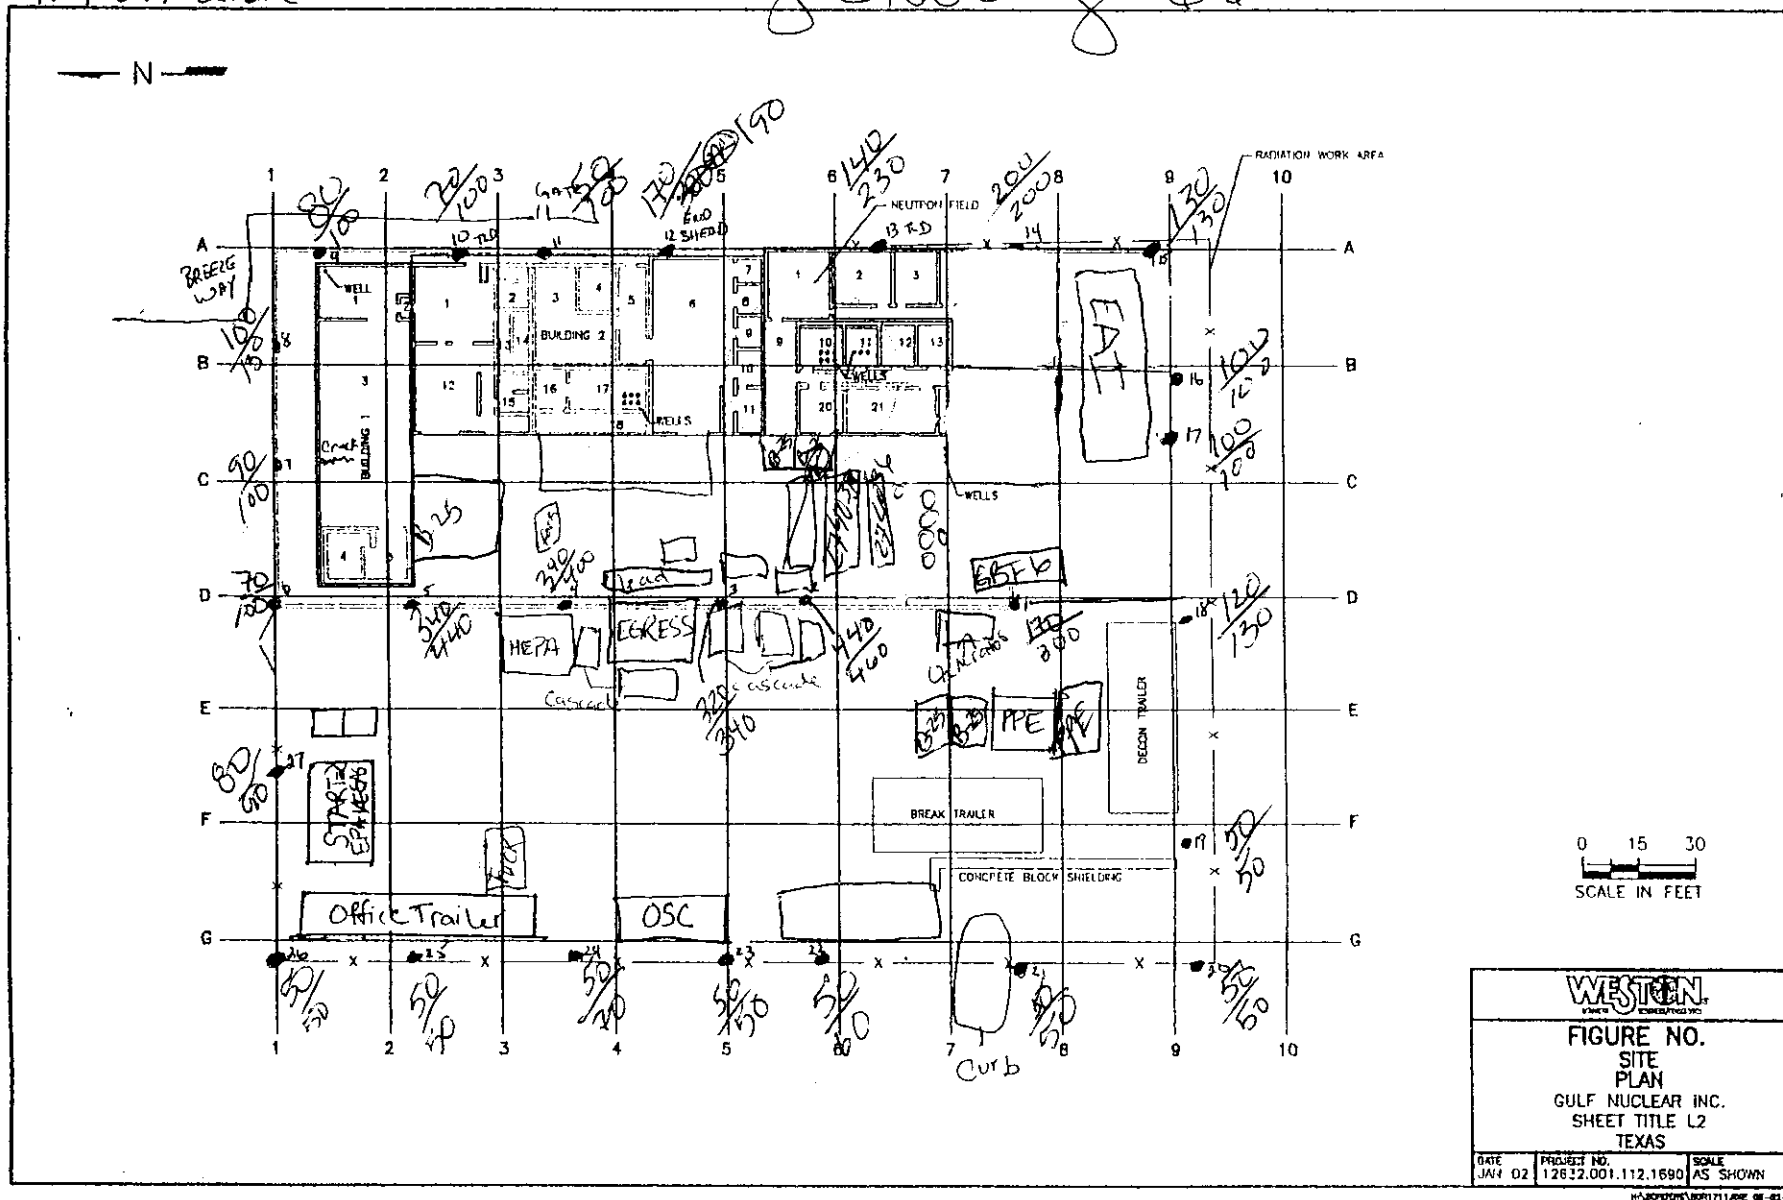

By: JAMES  
 READINGS AT 1 METER  
 MICRO R/HOUR MODEL 19 LUDLUM  
 #97549 SERIAL 77622

18 NOV. 2002  
 10:00 AM

2 METERS  
 +  
 1 METER

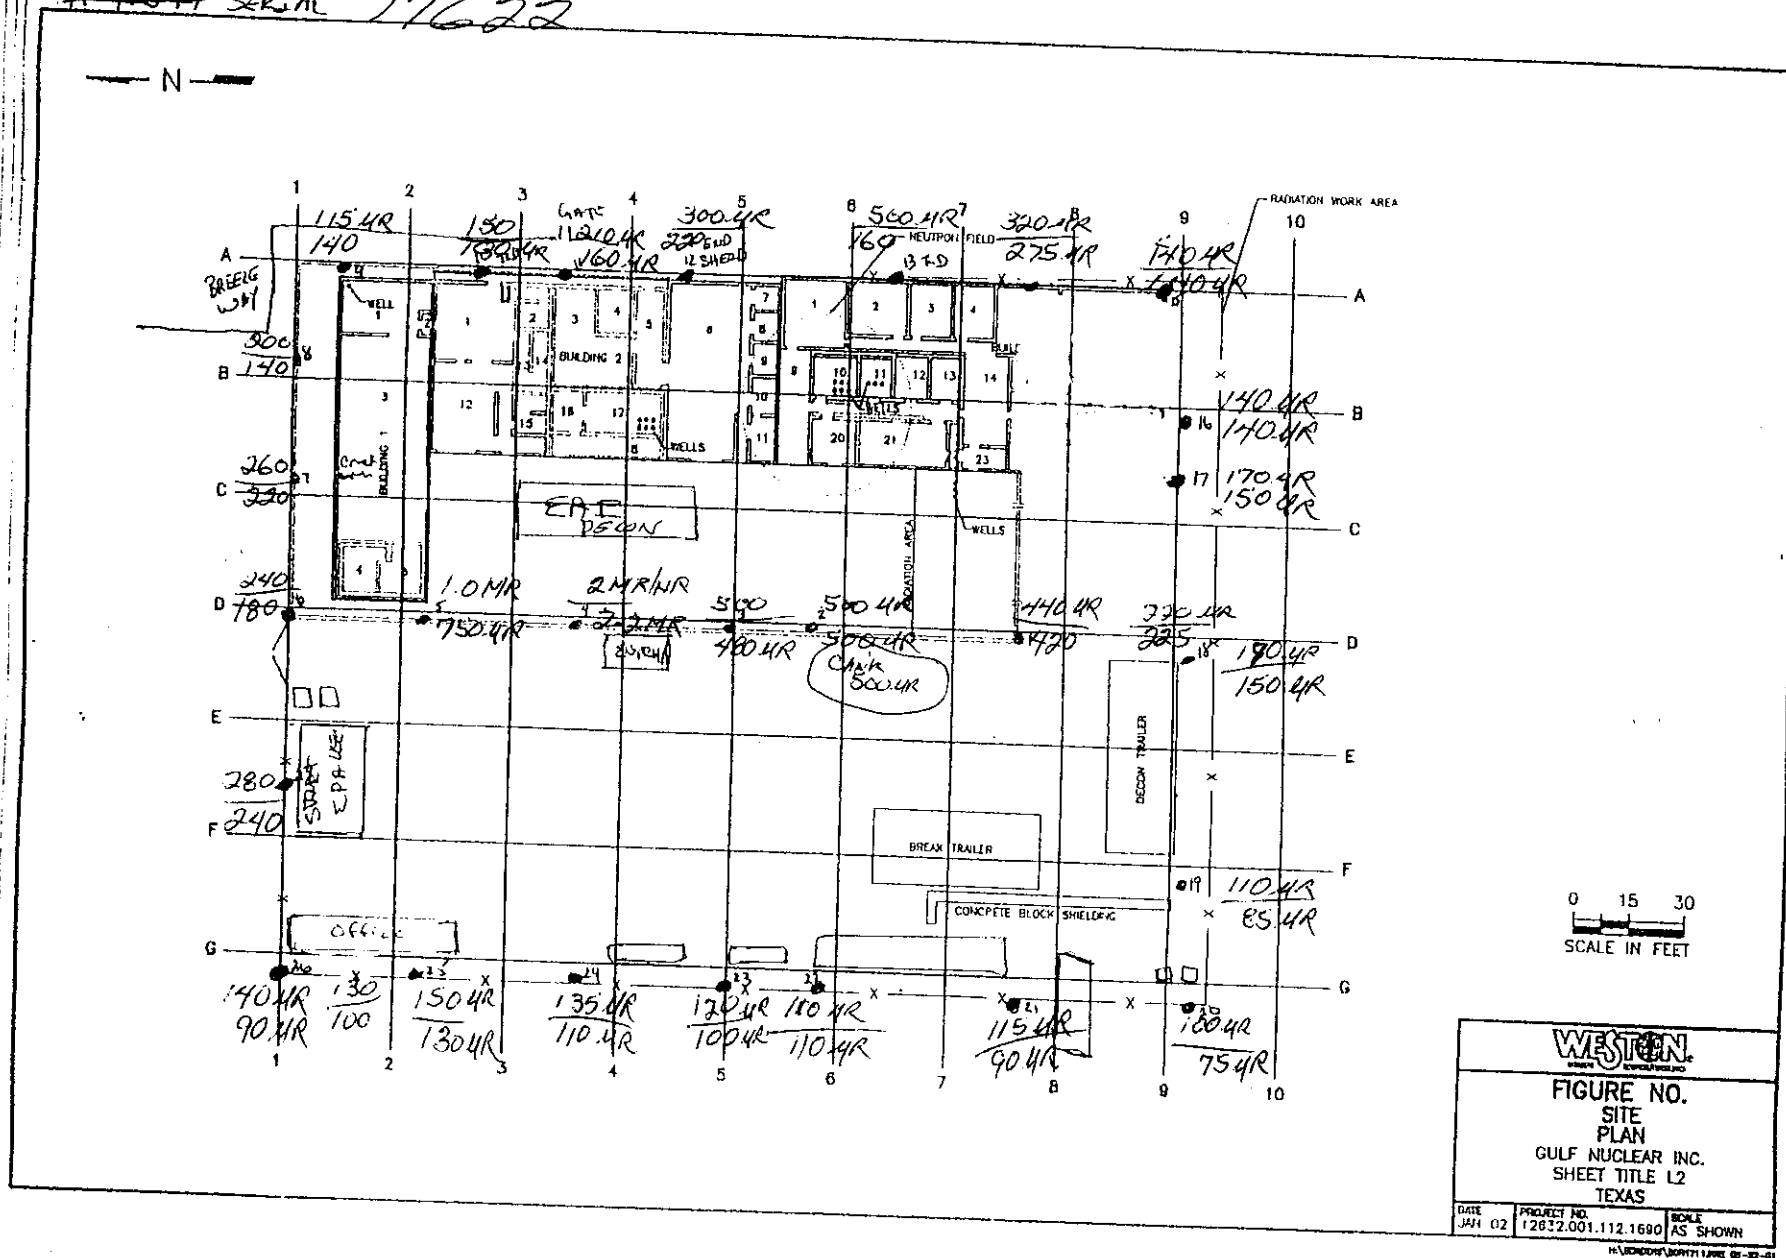


BY: JAMES 19 Nov. 2002 11:00 AM

READINGS AT 1 METER + 2 METERS

MICRO R/HOUR MODEL 19 LUDLUM


WELL # 91549 SERIAL 77622

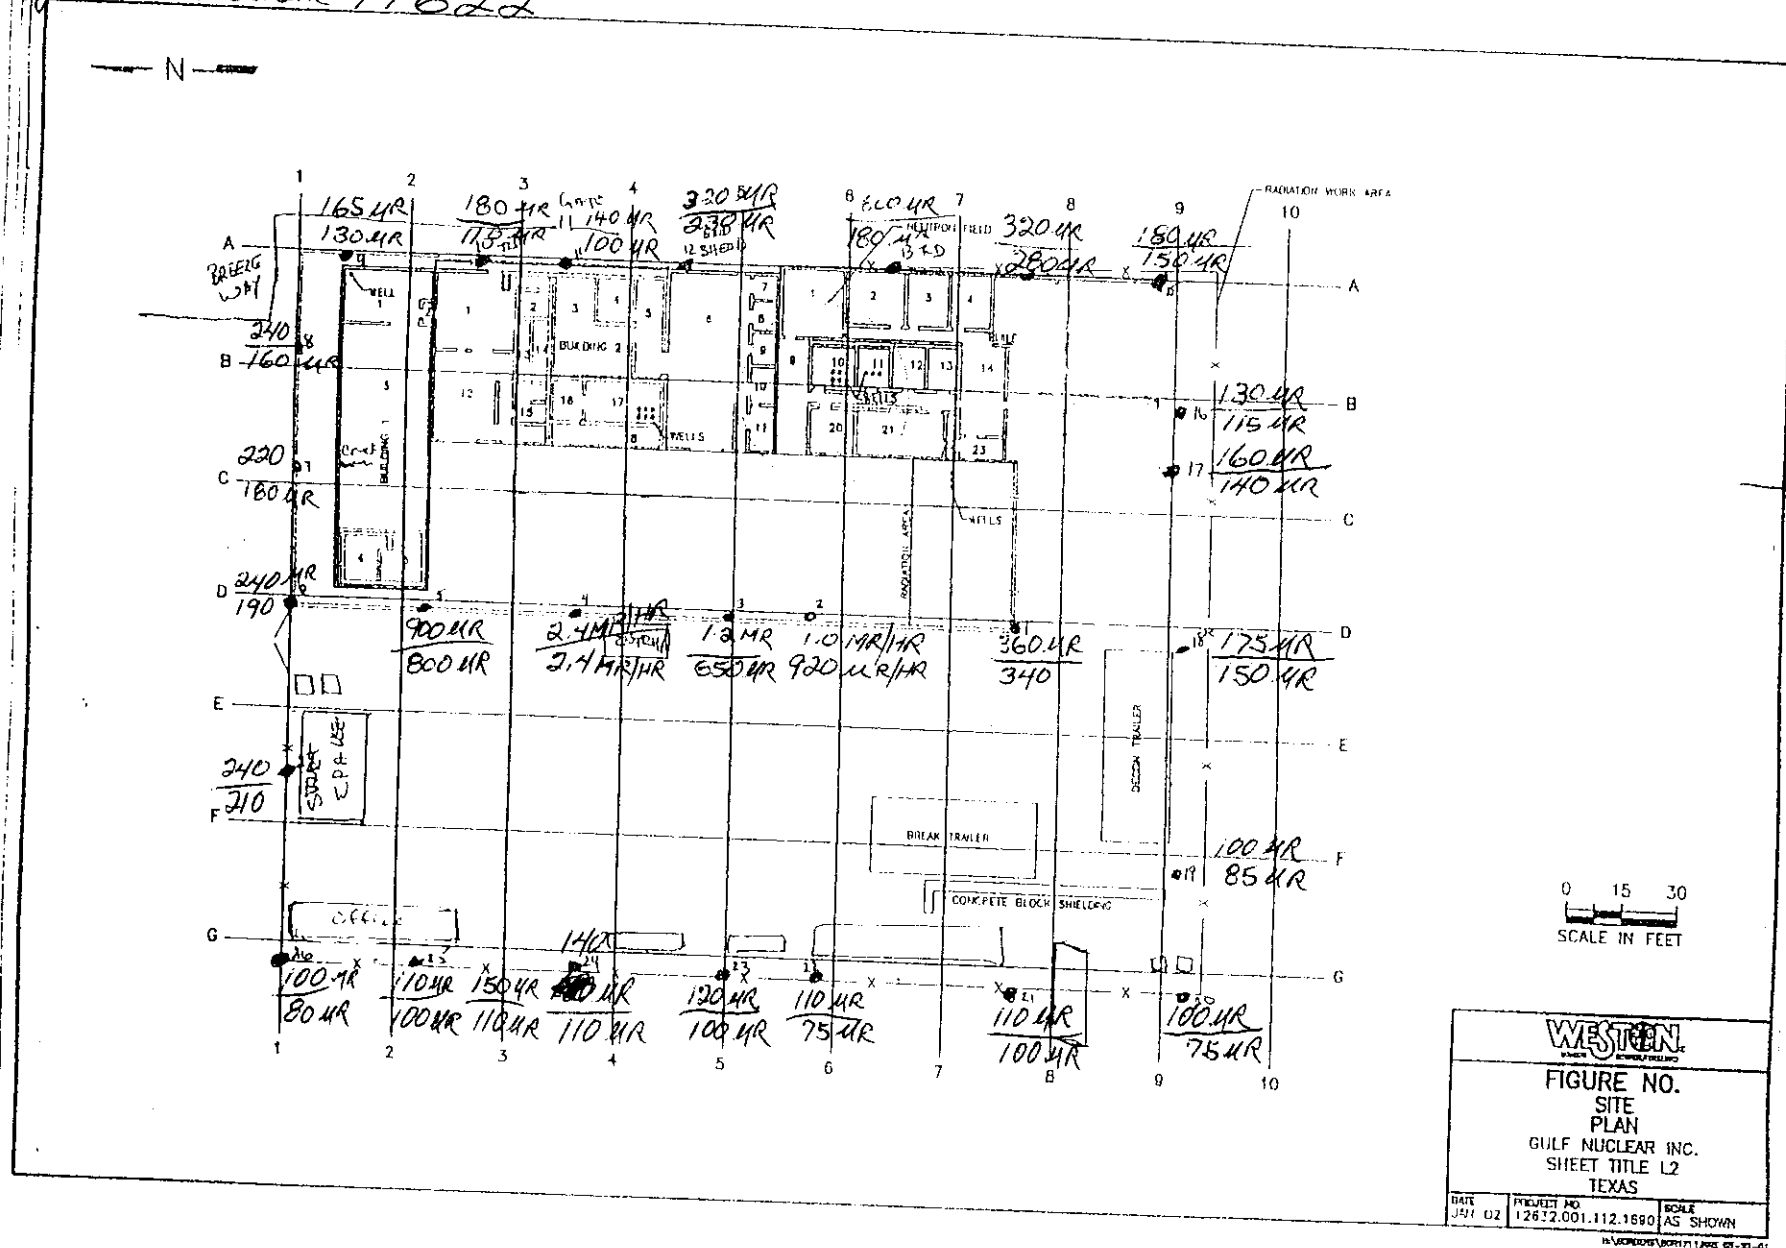

16/5

MICRO R/HOUR MODEL 19 LUCORNI

~~WJG # 91549~~ SERIAL 77622

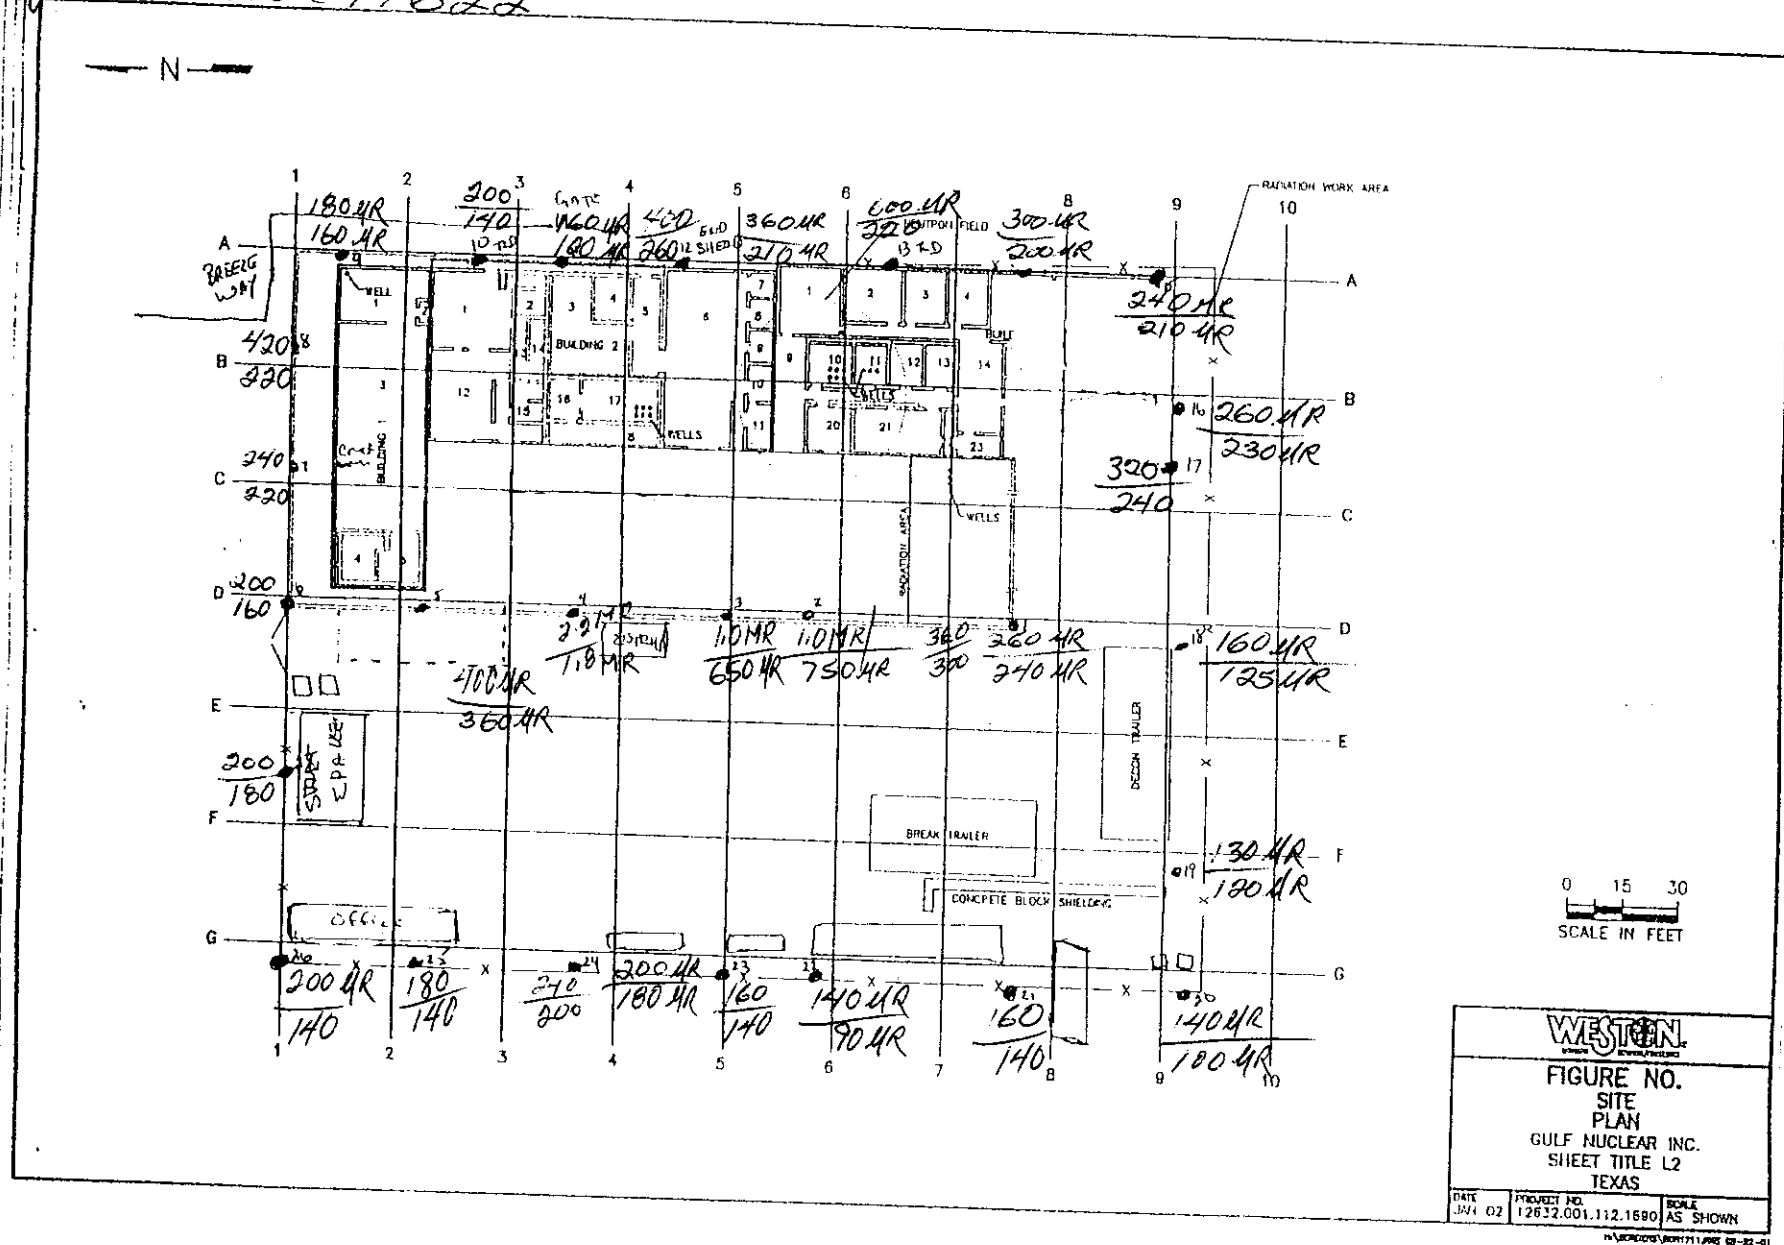


603. -35-

READINGS AT 1 METER + 2 METERS  
MICRO R/HOUR MODEL 19 (LOWLINE)  
~~2~~ # 91549 SERIAL 77622



START- 0955

END - 1030

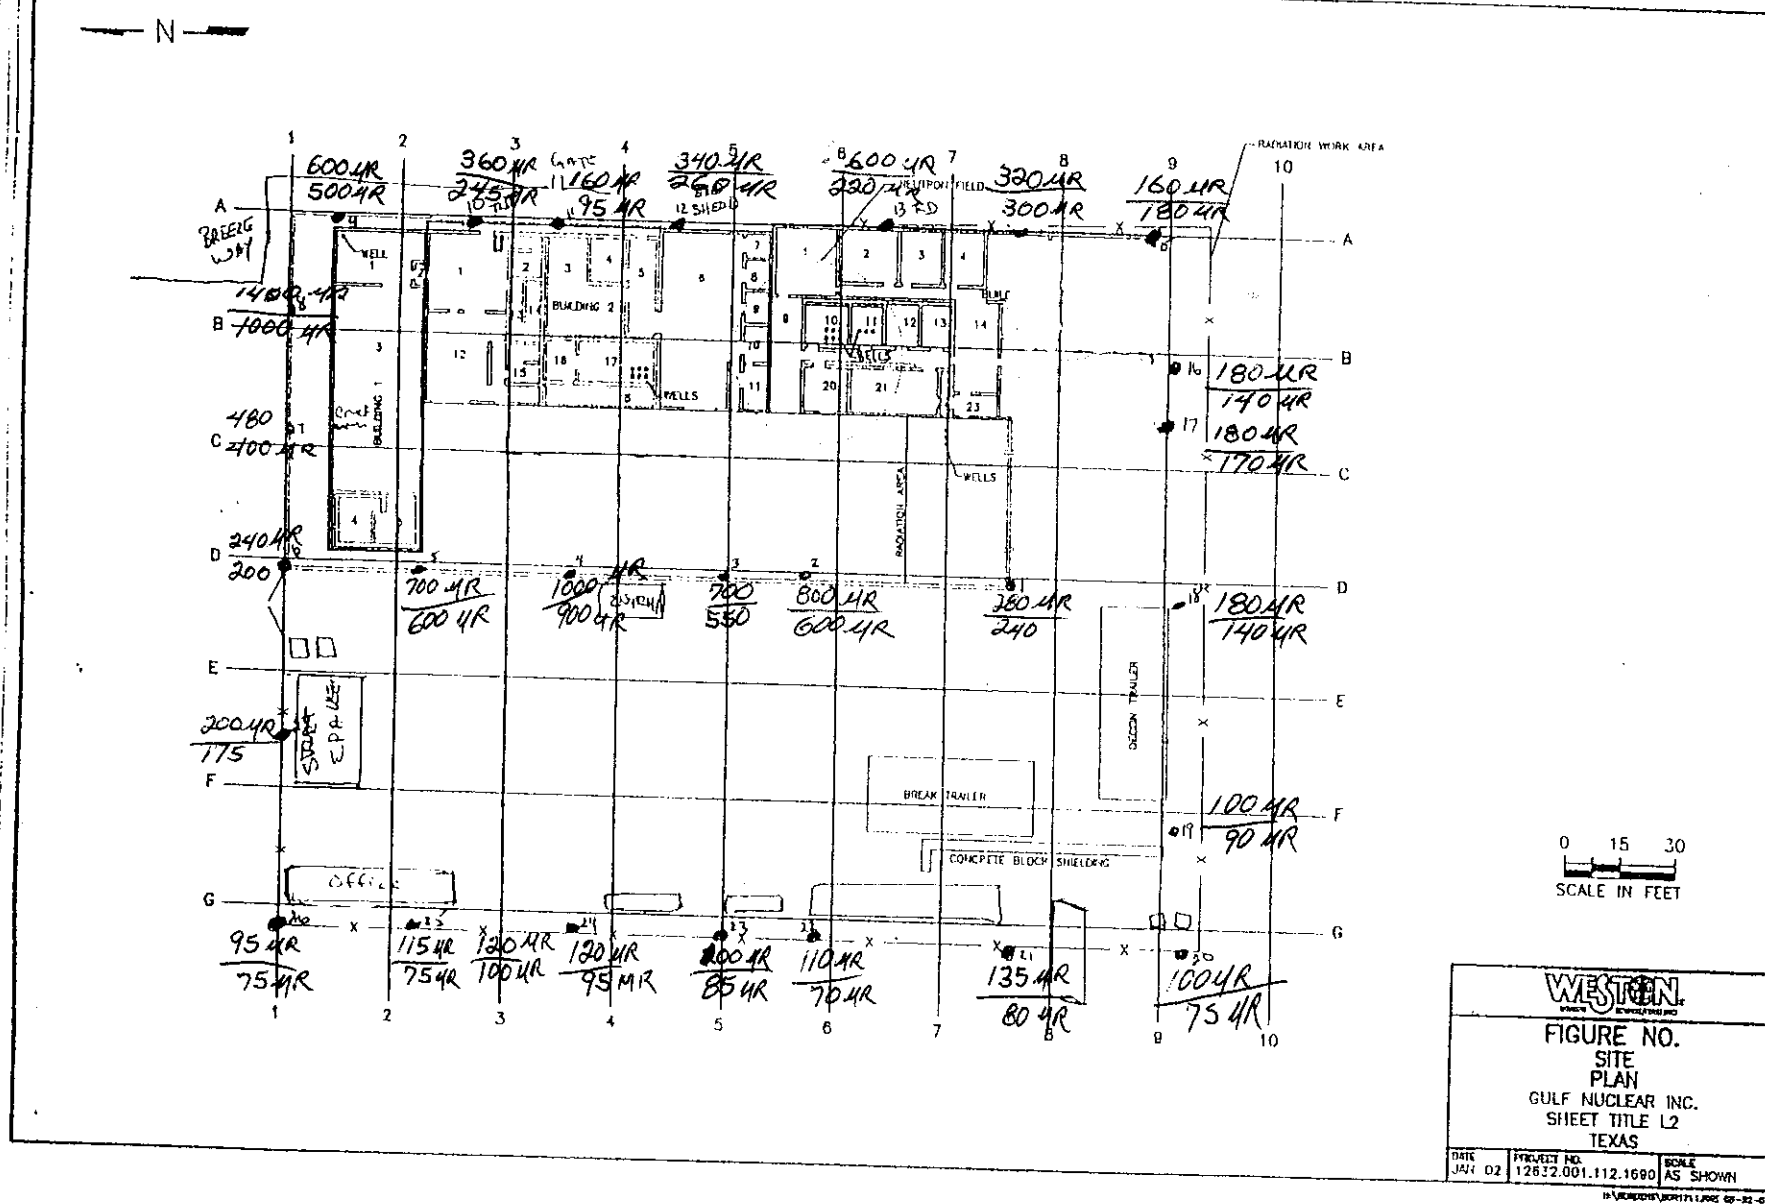

READINGS AT 1 METER + 2 METERS  
micro R/HOUR MODEL 15 Ludlum  
~~2~~ # 91549 SERIAL 77622

 1700

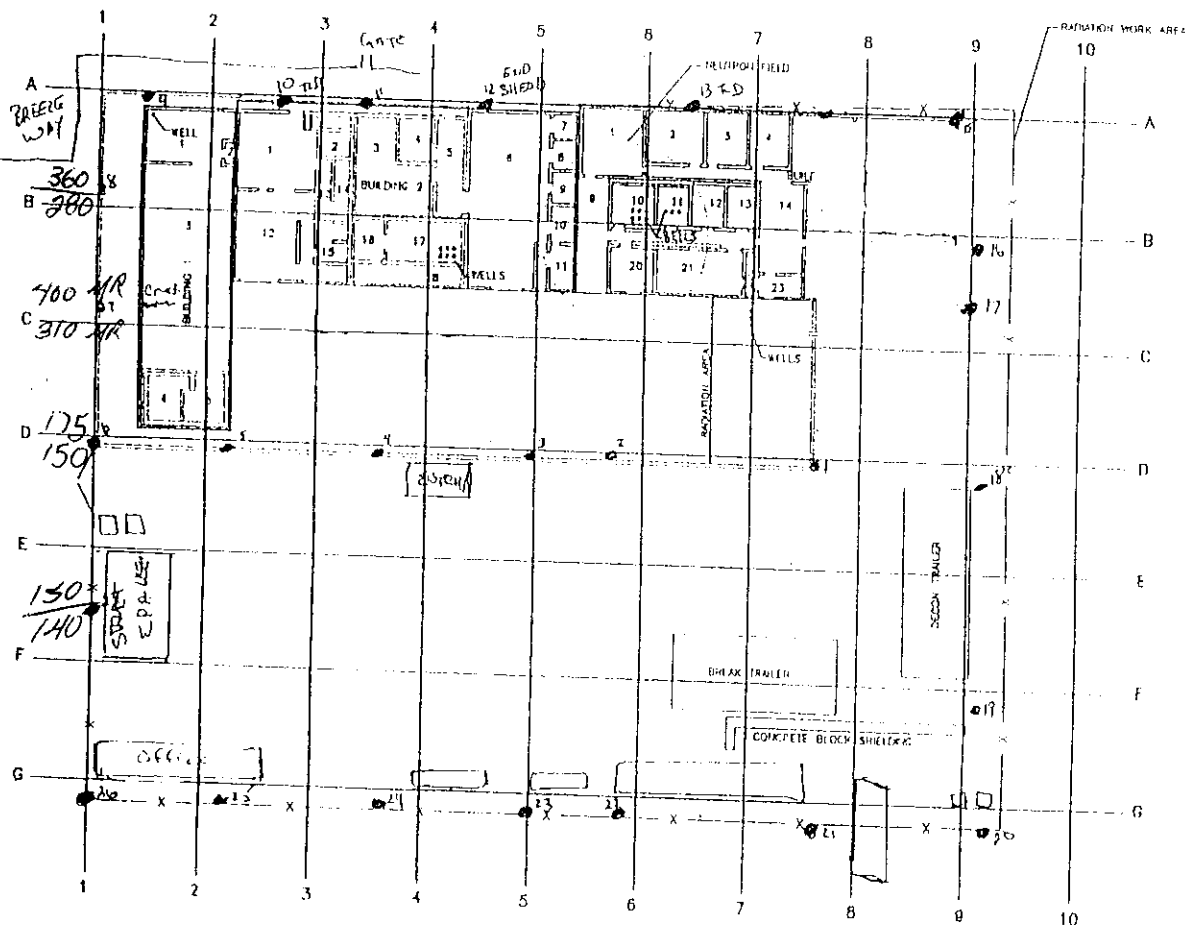

0 15 30  
SCALE IN FEET

**WESTERN**

FIGURE NO.  
SITE  
PLAN  
GULF NUCLEAR INC.  
SHEET TITLE L2  
TEXAS

DATE JUL 02	PROJECT NO. 12632.001.112.1680	SCALE AS SHOWN
----------------	-----------------------------------	-------------------

12. VINCENNES 1001711 JWS 69-12-01

BY: JAMES

READINGS AT 1 METER + 2 METERS

MICRO R/HOUR MODEL 19 LUDLUM


002# 91549 SERIAL 77622

22 Nov. 2002

MODEL 15 NEUTRON

SERIAL # 173771

JAMES

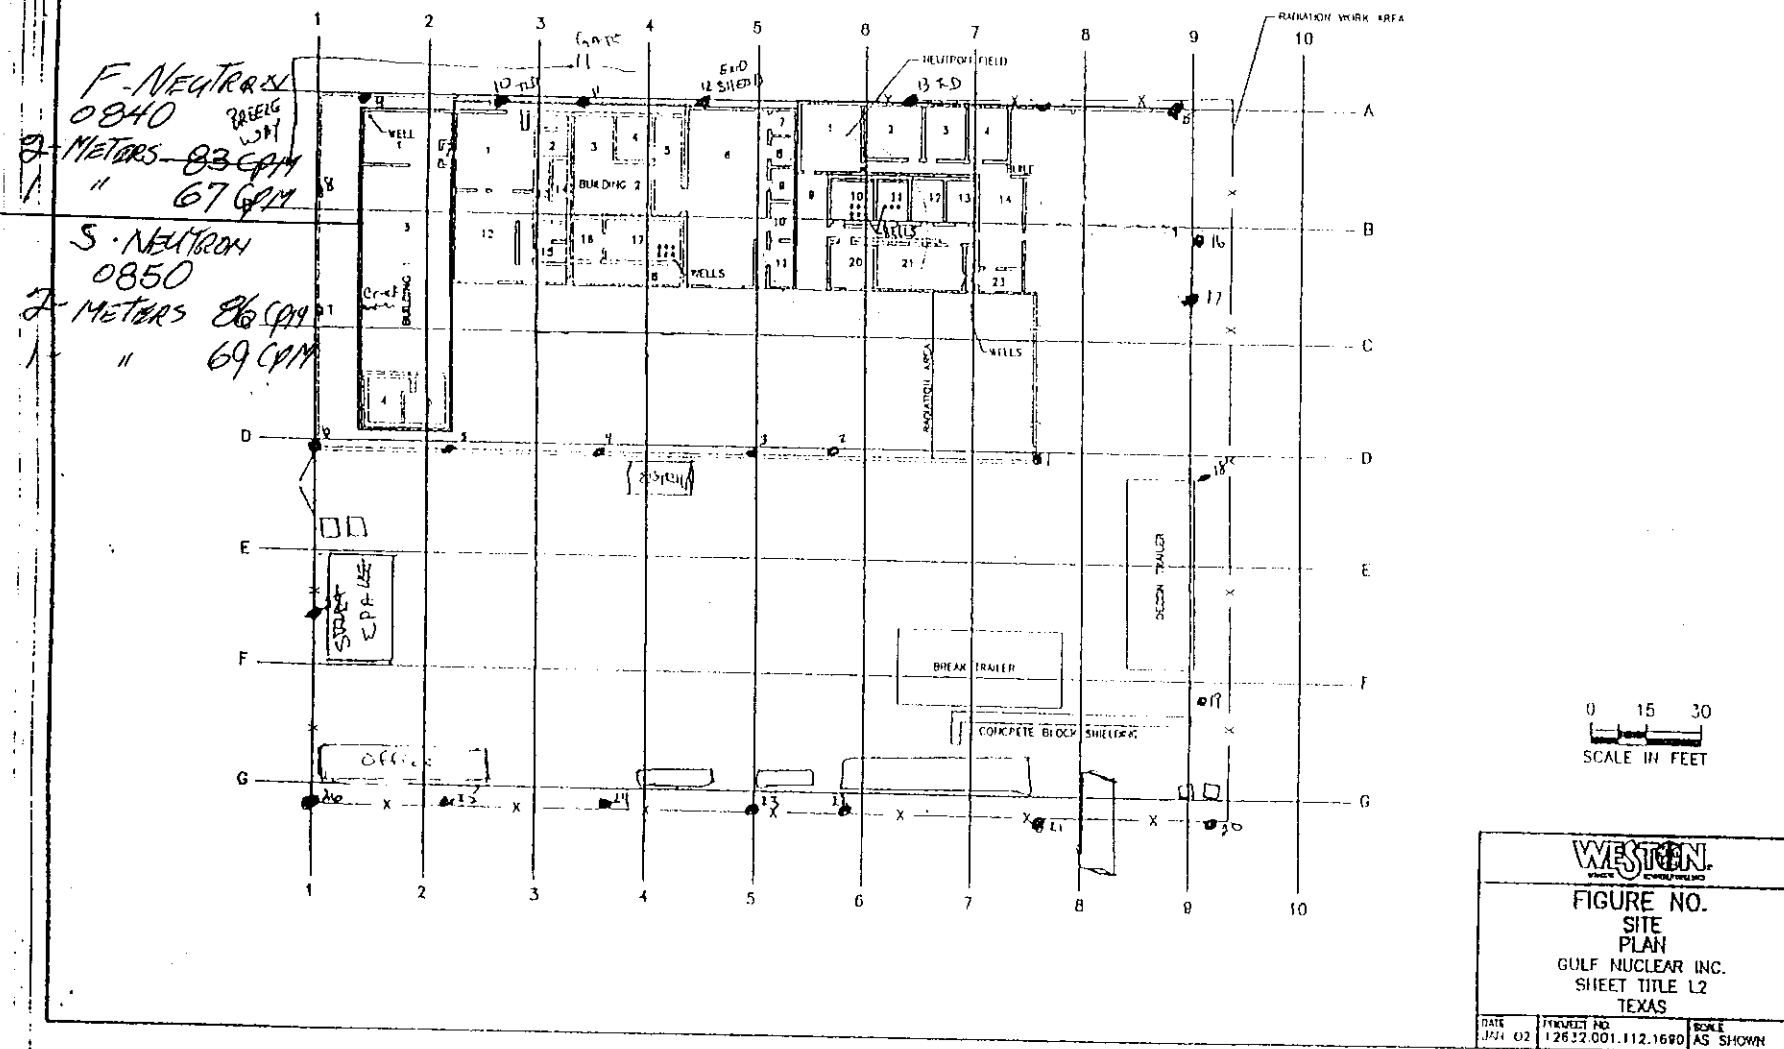



BY: JAMES

READINGS AT 1 METER + 2 METERS


MICRO R/HOUR MODEL 19 LOGIC

~~4429~~ # ~~91549~~ SERIAL 77622

22 Nov. 2002

START— 0805

END - 0830

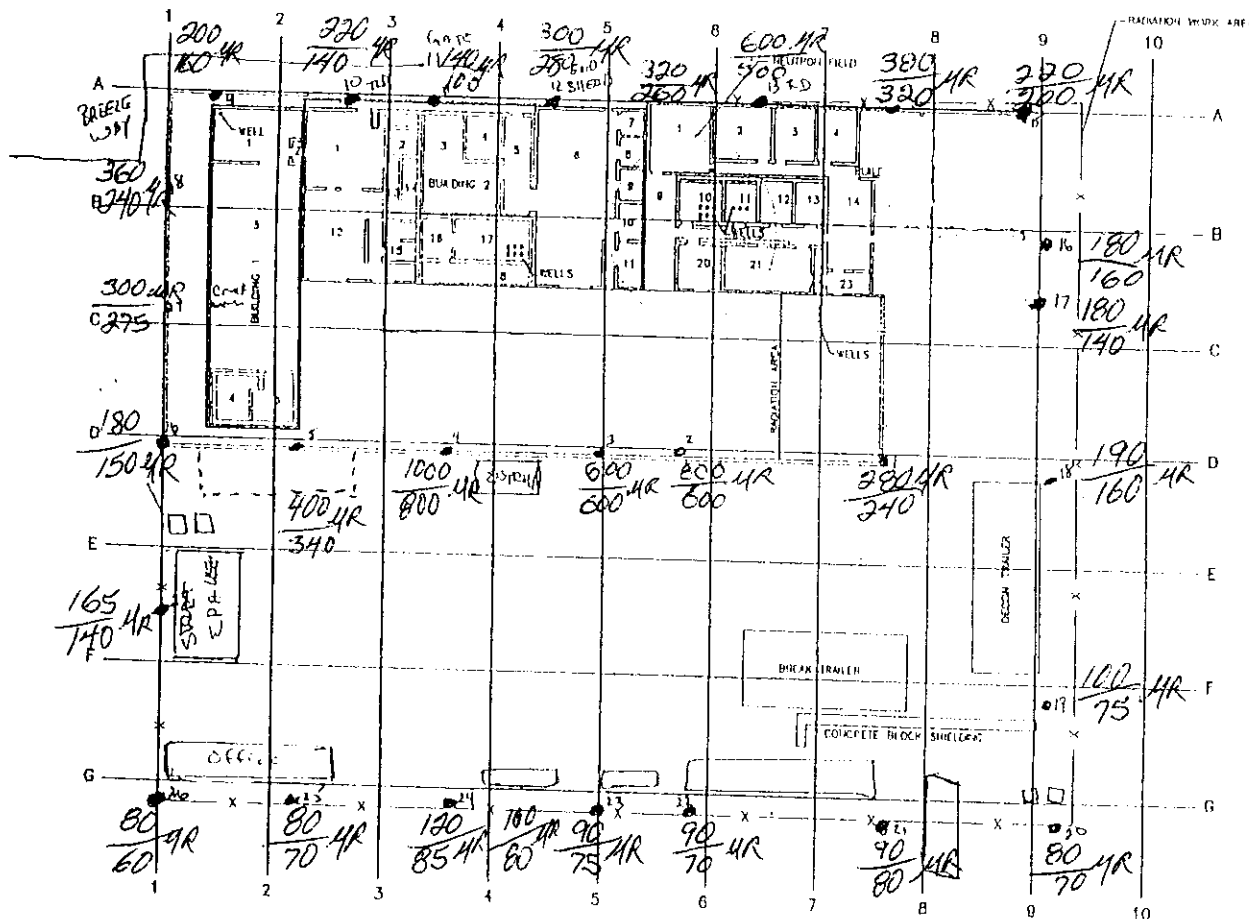

0 15 30  
SCALE IN FEET

**WESTON**

FIGURE NO.  
SITE  
PLAN  
GULF NUCLEAR INC.  
SHEET TITLE L2  
TEXAS


DATE JUL 02	PROJECT NO. 12612.001.112.1680	SCALE AS SHOWN
----------------	-----------------------------------	-------------------

14-00000

#91549 SERIAL

11/22/2002 1344  $\rightarrow$  1410

1400 - shutdown  
HVAC

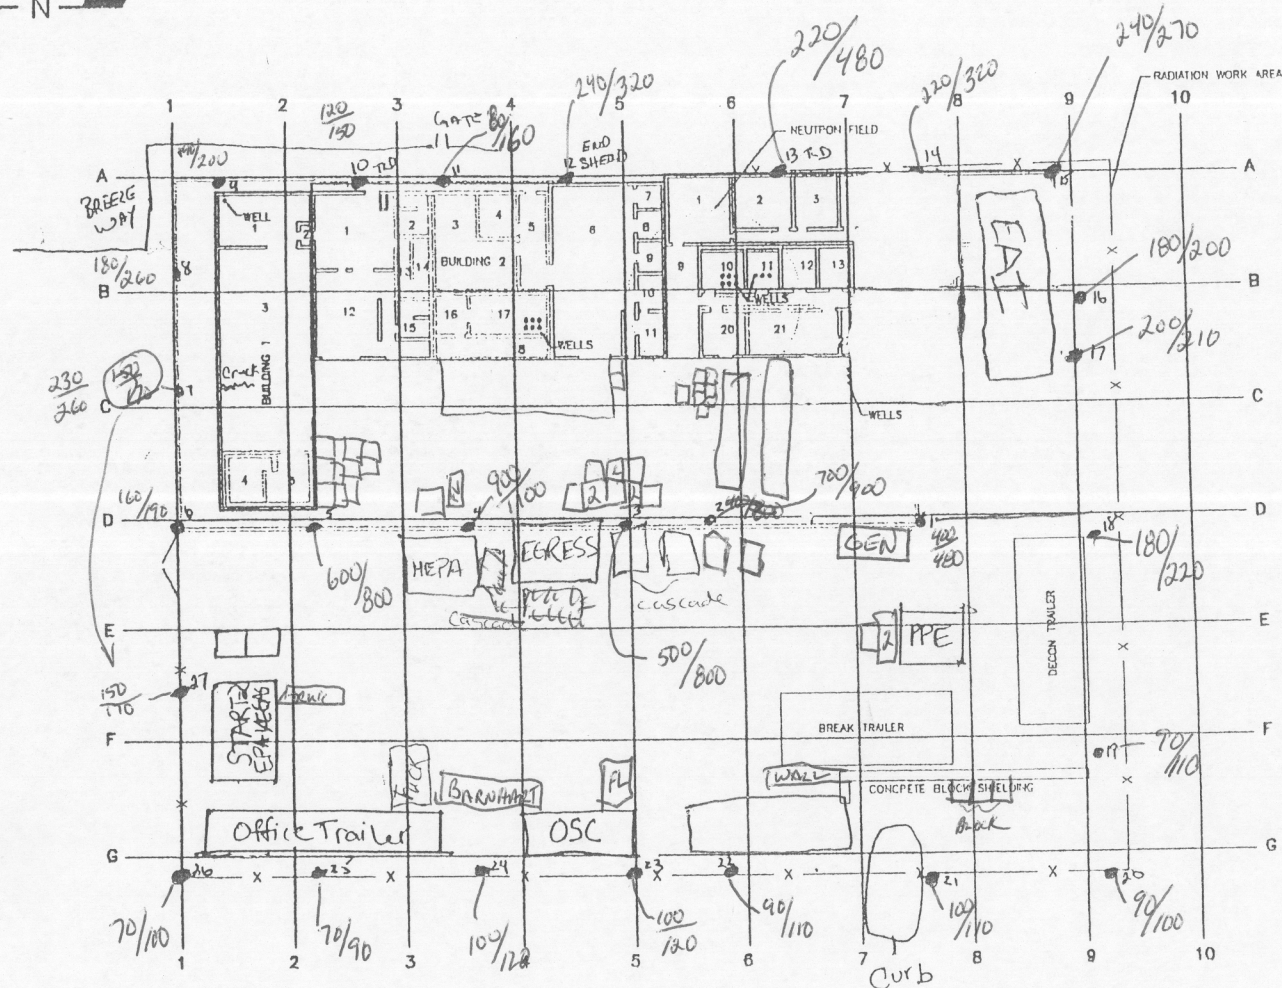

0 15 30  
SCALE IN FEET

**WESTON**

FIGURE NO.

### SITE PLAN

GULF NUCLEAR INC.  
SHEET TITLE L2  
TEXAS

DATE  
JAN 02

PROJECT NO.	12632.001.112.1690
-------------	--------------------

0 SCALE  
AS SHOWN

NY 100-171102-08-00